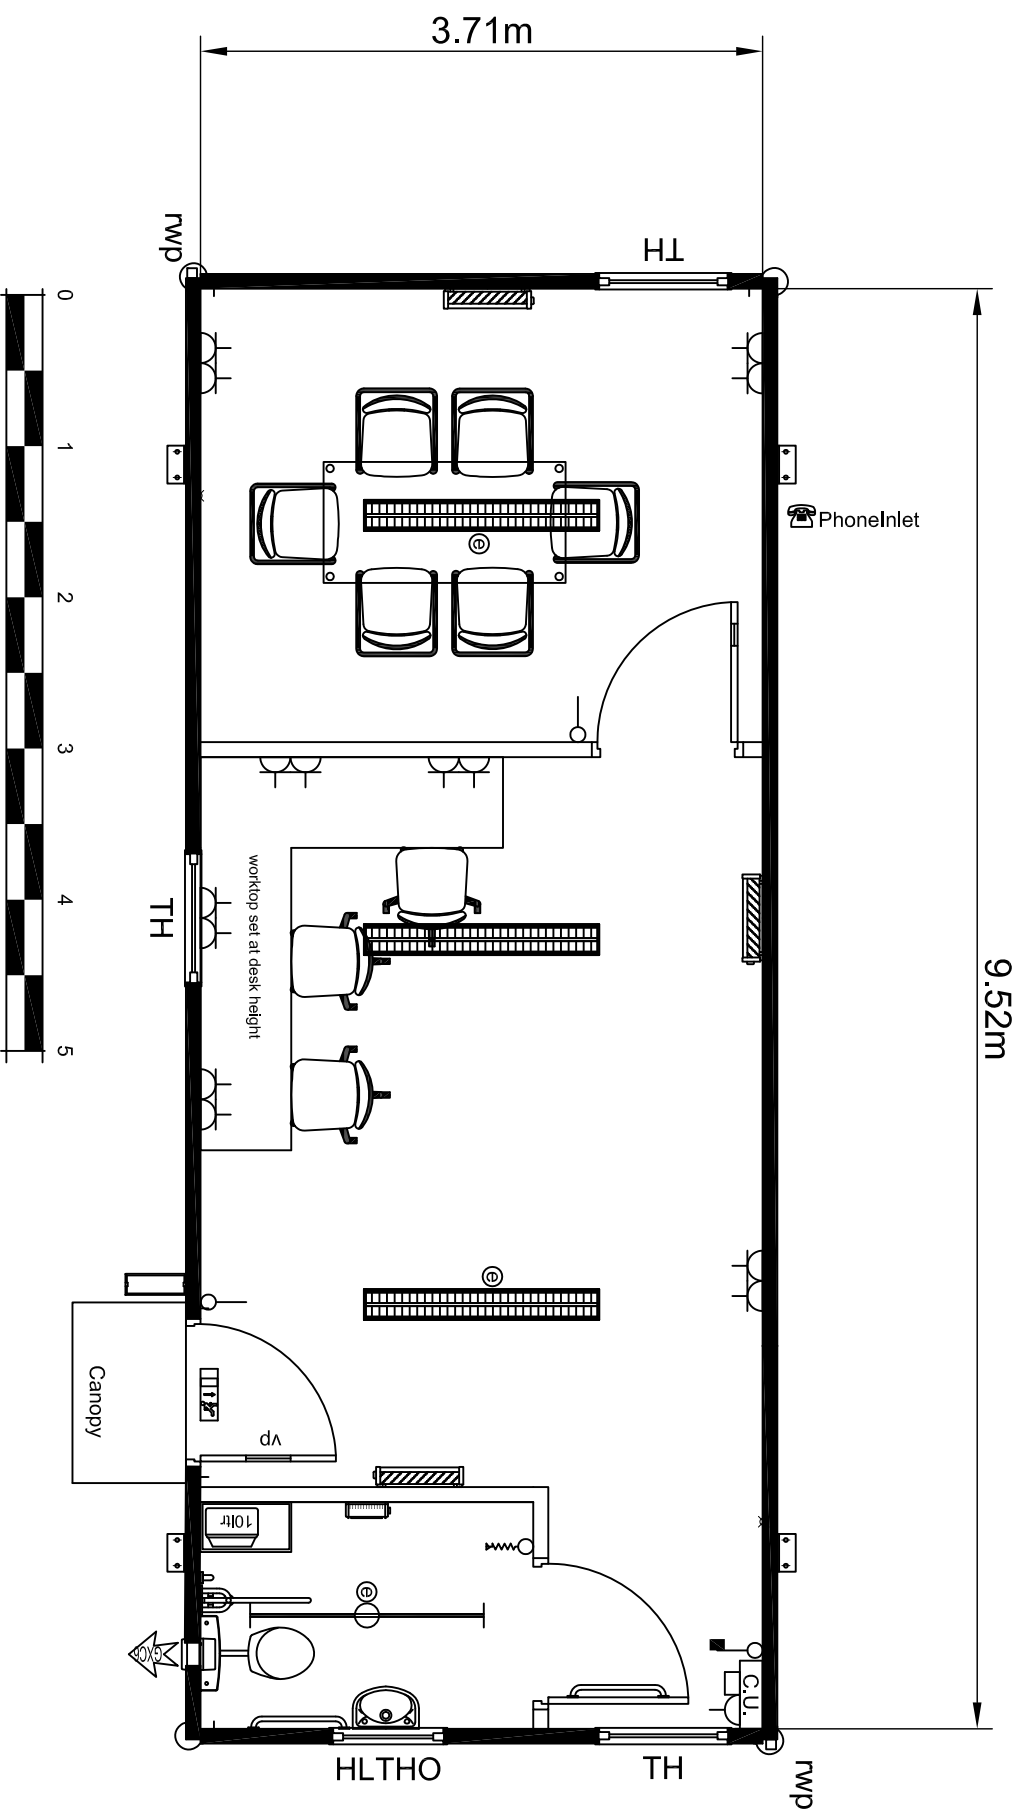



 
 


 








 
TN104 Titan Building

Do not scale off this drawing. All discrepancies to be reported to Portakabin Limited.

5m



- NOTE:
- BUILDING IN GOOSEWING GREY 10A05
 - FASCIA IN TRAFFIC GREY RAL 7042
 - EXTERNAL DOOR PANLE & WINDOW FRAMES IN ANTHRACITE RAL 7016
 - LED LIGHTING THROUGHOUT
 - ELECTRIC HEATING THROUGHOUT
 - CARPET TILES TO OFFICE AREAS IN GRAPHITE GREY
 - VINYL FLOORING TO WC AREA IN FLINT GREY
 - PLUMBING SERVICES THROUGH THE WALL
 - WORKTOP IN OFFICE SET AT DESK HEIGHT 720MM
 - FURNITURE SHOWN FOR LAYOUT PURPOSE ONLY

	Single phase consumer unit		1 gang, 1 way light switch		1.5m LED light fitting
	Heating controller & spur		1 way pull switch		1.5m LED light fitting with emergency light
	2 gang switched socket		150mm extract fan		1.5m LED light fitting with emergency light c/w diffuser
	2kW convector heater		H/L 1kW fan heater c/w frost protection		10 litre unvented water heater
	3hr, N/M emergency light c/w legend		3hr, N/M LED emergency light		Emergency light key test switch

Floor Area 35.40 m²
Ceiling Height 2.5 m

Window Key

TH = Top Hung
HLTHO = High Level Top Hung & Obscure

Rev	Item	Name	Date
.	.	.	.

Portakabin

Portakabin Limited Huntingdon York YO32 9PT
Telephone 01904 611655 Fax 01904 611644

Project	OFFICE & MEETING ROOM		
Client	London Borough of Southwark		
Title	Floor Plan	Date	17/02/20
		Drawn	L Hodgson
		Scale	1:50 @ A3
		Dwg. No.	OPP1160723
		Rev.	